





 






KEY TO SYMBOLS

DESCRIPTION	QTY
 PROPOSED SWITCH	2
 TRANSFORMER	2
 WEATHERPROOF GPO	2
 GARDEN SPHERE LIGHT	12
 BUNKER STAIR LIGHT	3
 IN GROUND DECK LIGHT	4

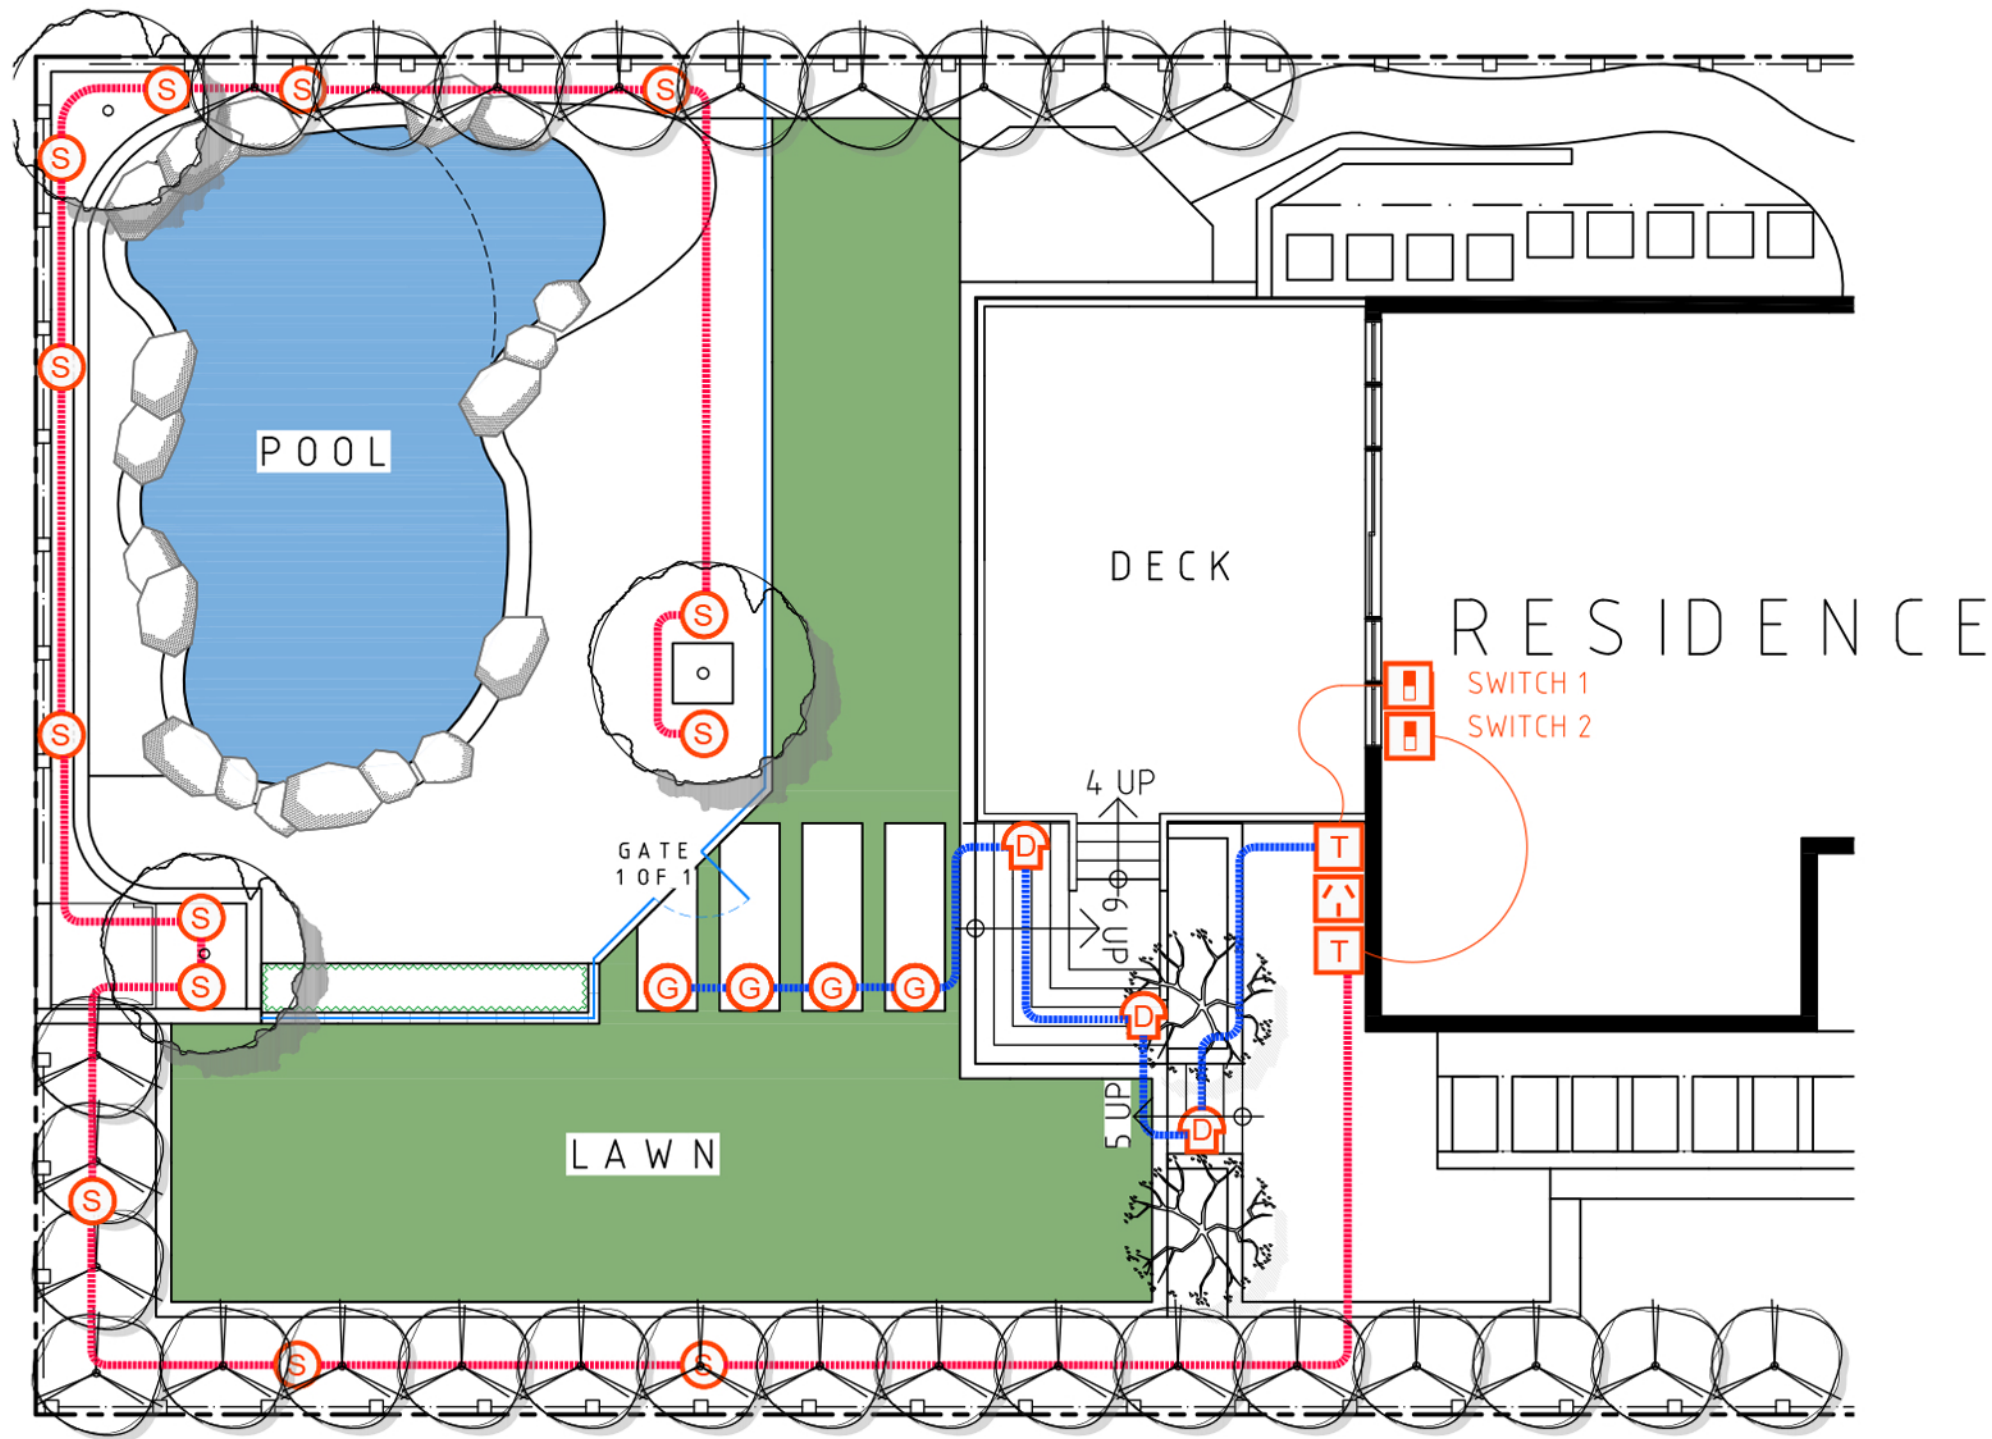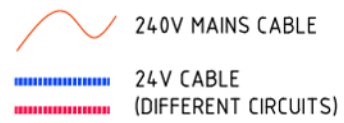

ANDREWS RESIDENCE

SITE ADDRESS: [REDACTED]

DWG TITLE:

LIGHTING PLAN

DWG NO.

2

REV.

-

SCALE: 1:100@A3

DATE: 25 August 2016

